


ELECTRICAL LEGEND

- ▶ DOUBLE POWER POINT
- ▶ EXTERNAL POWER POINT
- ▶ S. SHAVER POWER POINT
- ▶ Isol. ISOLATOR
- LIGHT SWITCH ON DIMMERS
- DOUBLE LIGHT SWITCH ON DIMMERS
- ▶ Tv. TELEVISION
- ▶ Tel. TELEPHONE
- ▬ HEATED TOWEL RAIL

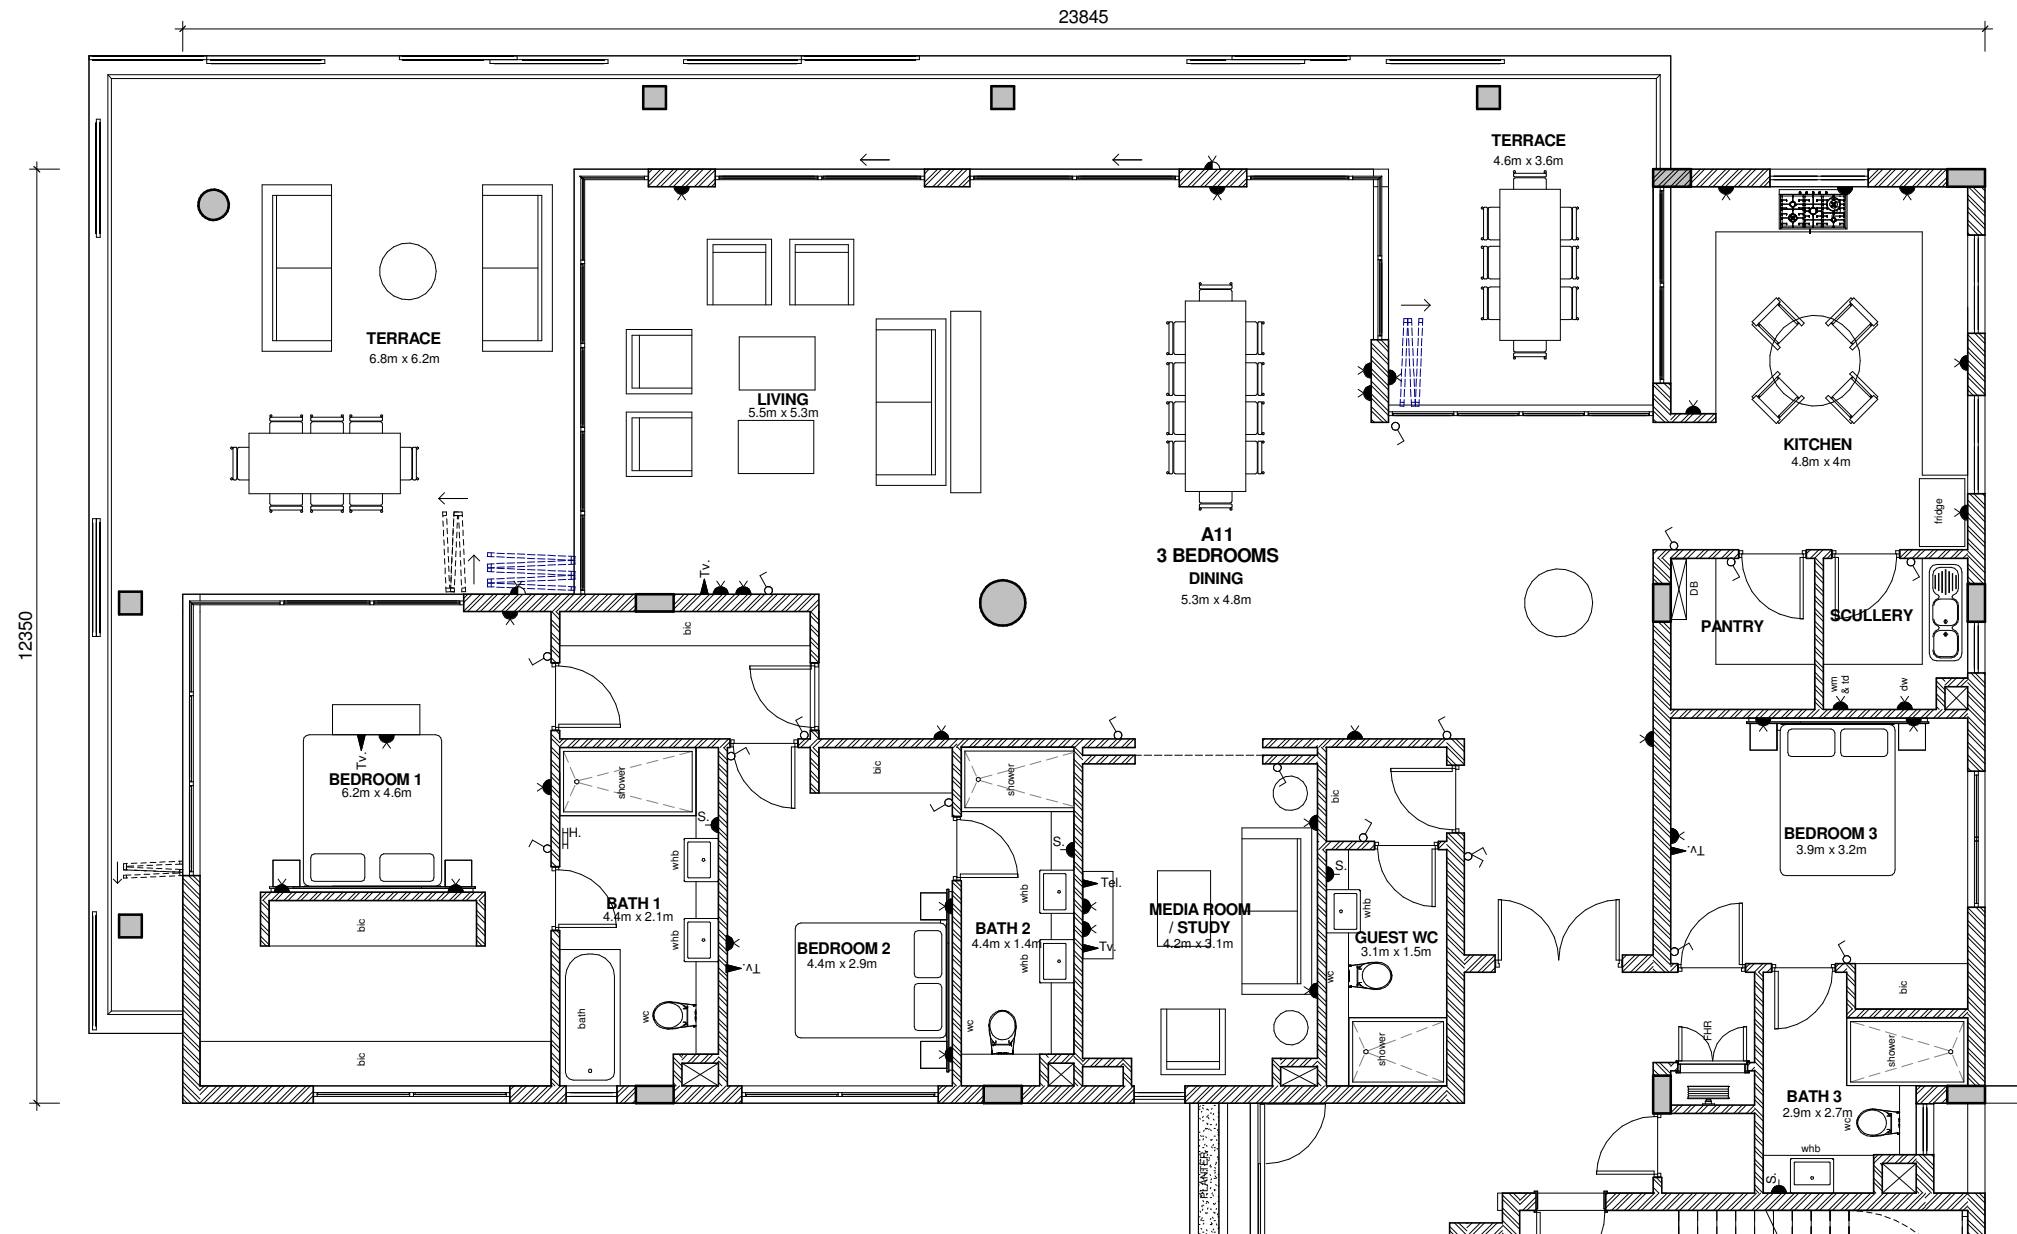

A11 - 3 BEDROOMS

SCALE - 1 : 50
SCALE- 1:100 @ A3

Scale 1 : 50



| | | | |
|---------------------|-------------------|----------------------------------|-------------------|
| UNIT NUMBER | A11 | TERRACE / BALCONY / PATIO | 86m ² |
| LAYOUT | 3 Bedrooms | PRIVATE LANDING | 0m ² |
| ROOF GARDEN | 0m ² | PARKING BAYS x2 | 25m ² |
| SECTION AREA | 252m ² | GROSS AREA | 363m ² |

| | | |
|-------------|----------------|------------------|
| DATE | WITNESS | PURCHASER |
|-------------|----------------|------------------|

THIS PRINT SUPERCEDES
ANY PREVIOUS ISSUE
**22 OCTOBER
2014**
LOUIS KAROL

| REV | DATE | DESCRIPTION | BY |
|-----|----------|--|----|
| 1 | 20141008 | ELECTRICAL AND LIGHTING LAYOUTS REVISED. | SV |

REVISION SCHEDULE

FOR INFORMATION

2nd FLOOR, THE PALMS
145 SIR LOWRY ROAD
CAPE TOWN 8001
PO BOX 366
CAPE TOWN 8000
tel: +27 21 462 4500
fax: +27 21 462 4550
info@louiskarol.com
www.louiskarol.com

318 ROSEBANK MEWS
2nd FLOOR, 173 OXFORD
ROAD, ROSEBANK 2196
PO BOX 676
PARKLANDS, JHB 2121
tel: +27 11 447 2011
fax: +27 11 447 2021




PROJECT
IZINGA PARK
DURBAN

| | | | |
|---|--------|----------|----------|
| DRAWING | SCALE | 1 : 50 | A1 |
| MARKETING PLAN A11 - 3 BEDROOMS FURNITURE PLAN | | Author | Checked |
| DRAWING NUMBER | ISSUED | 09/16/14 | REVISION |
| 201326 01 119 | | | 1 |


CEILING LEGEND

- ⬢ L1 INTERNAL RECESSED SOFFIT DOWNLIGHT
- ⬢ L2 EXTERNAL SOFFIT MOUNTED LIGHT
- ⬢ DOWN LIGHT
- ▬ RECESSED EXTERNAL WALL LIGHTS
- - - FLUORESCENT LIGHT 1
- FLUORESCENT LIGHT 2
- ▨ 2400mm AFFL SOFFIT
- ▩ 2450mm AFFL PLASTERBOARD CEILING
- ▧ 2780mm AFFL SOFFIT
- ▦ 2800mm AFFL PLASTERBOARD CEILING
- 2950mm AFFL SOFFIT

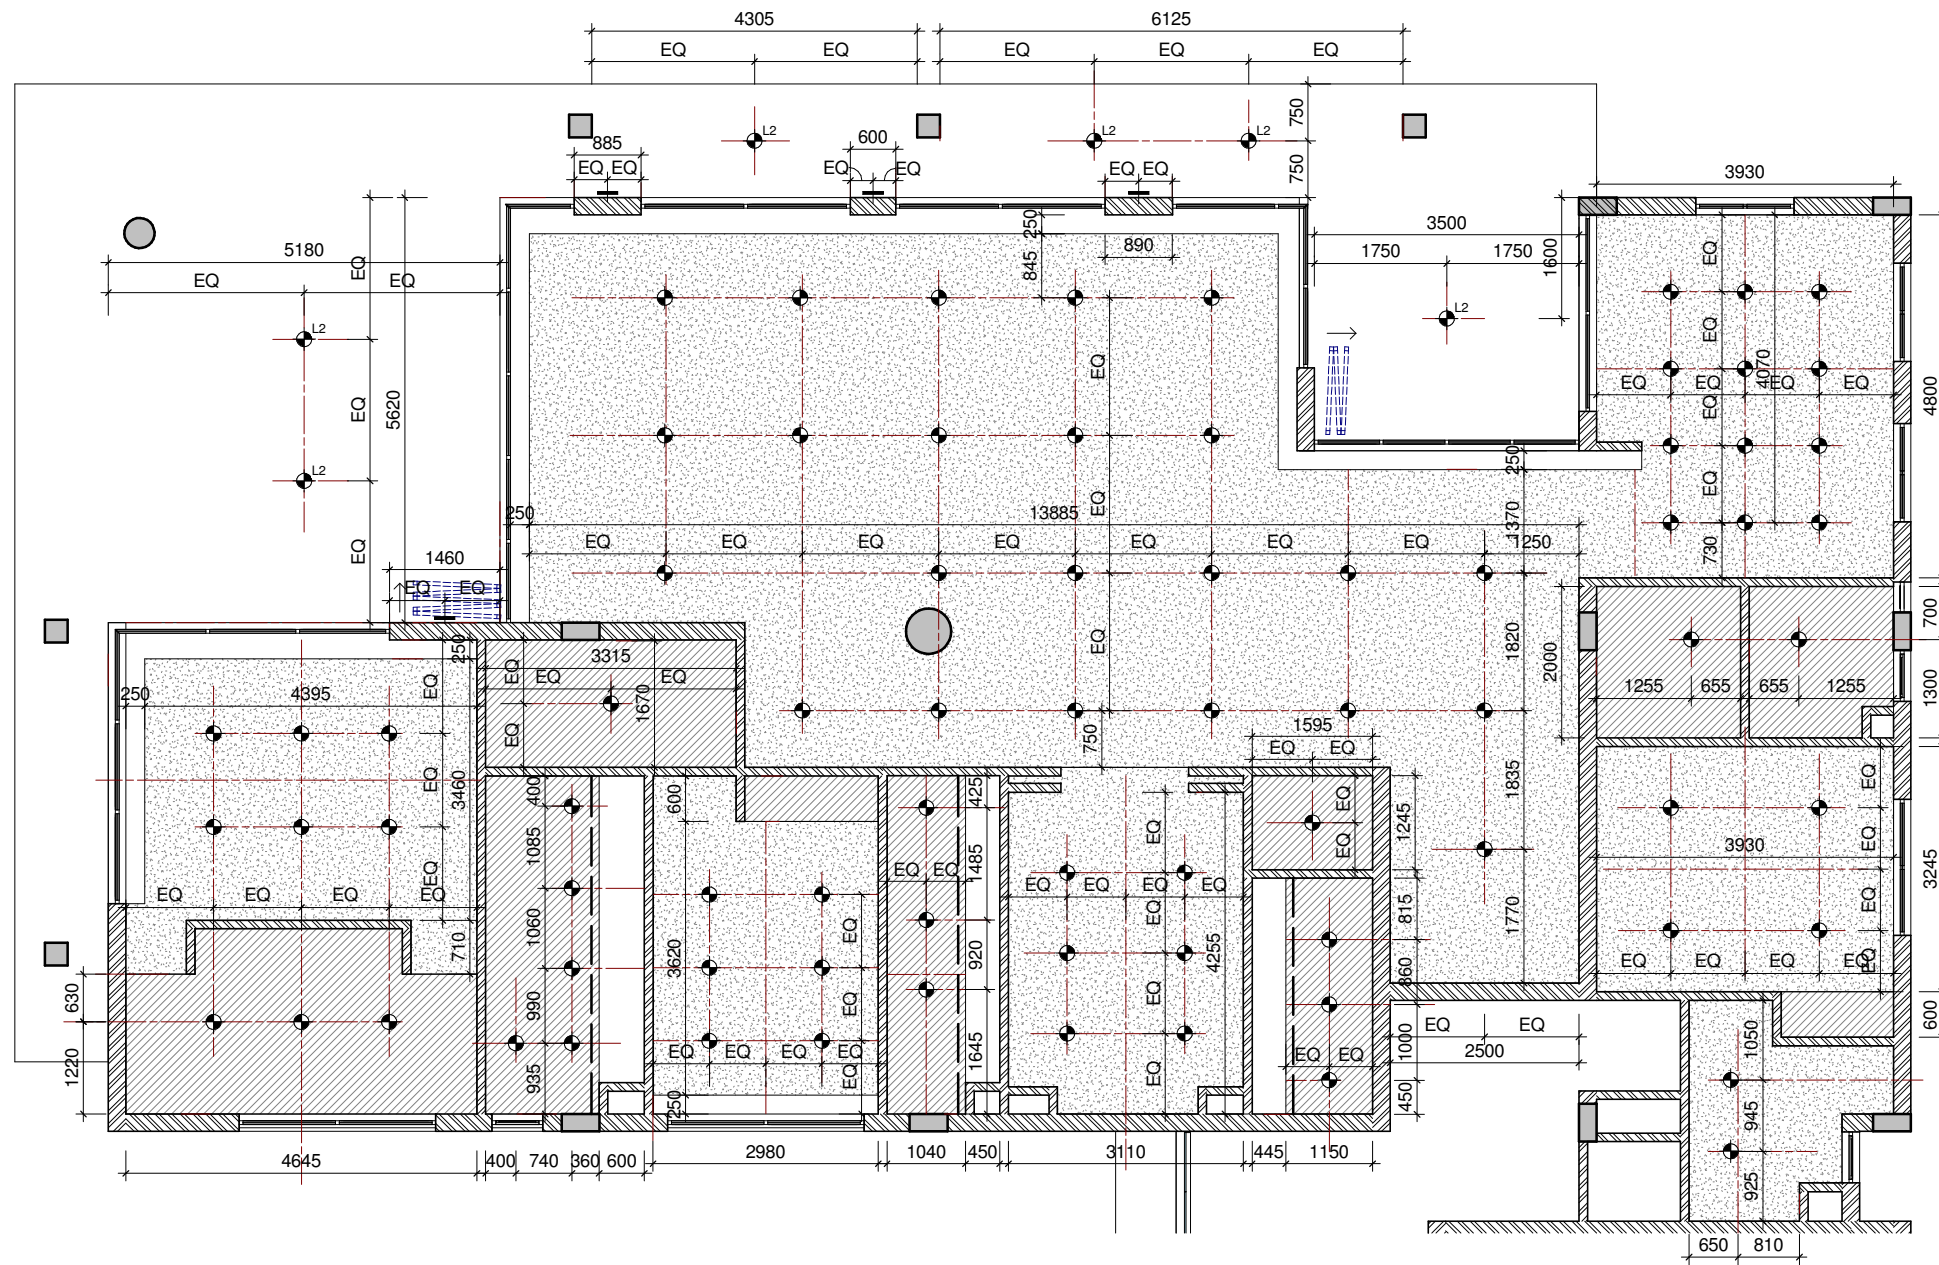

A11 - 3 BEDROOMS

 SCALE - 1 : 50
SCALE - 1:100 @ A3



| | | | |
|---------------------|-------------------|----------------------------------|-------------------|
| UNIT NUMBER | A11 | TERRACE / BALCONY / PATIO | 86m ² |
| LAYOUT | 3 Bedrooms | PRIVATE LANDING | 0m ² |
| ROOF GARDEN | 0m ² | PARKING BAYS x2 | 25m ² |
| SECTION AREA | 252m ² | GROSS AREA | 363m ² |

| | | |
|-------------|----------------|------------------|
| DATE | WITNESS | PURCHASER |
|-------------|----------------|------------------|

THIS PRINT SUPERCEDES ANY PREVIOUS ISSUE
22 OCTOBER 2014
LOUIS KAROL

| REV | DATE | DESCRIPTION | BY |
|-----|----------|--|----|
| 1 | 20141008 | ELECTRICAL AND LIGHTING LAYOUTS REVISED. | SV |

REVISION SCHEDULE

FOR INFORMATION

2nd FLOOR, THE PALMS
145 SIR LOWRY ROAD
CAPE TOWN 801
PO BOX 366
CAPE TOWN 800

3rd FLOOR, MENS
2nd FLOOR, 173 OXFORD
ROAD, ROSEBANK 2196
PO BOX 676
PARKLANDS, JHB 2121

LOUIS KAROL

architecture
engineering
interiors

PROJECT
**IZINGA PARK
DURBAN**

| | | | |
|--|---------|----------|----------|
| DRAWING | | SCALE | |
| MARKETING PLAN A11- 3 BEDROOMS CEILING PLAN | | 1 : 50 | A1 |
| Author | Checked | ISSUED | 09/16/14 |
| 201326 01 120 | 1 | REVISION | 1 |