
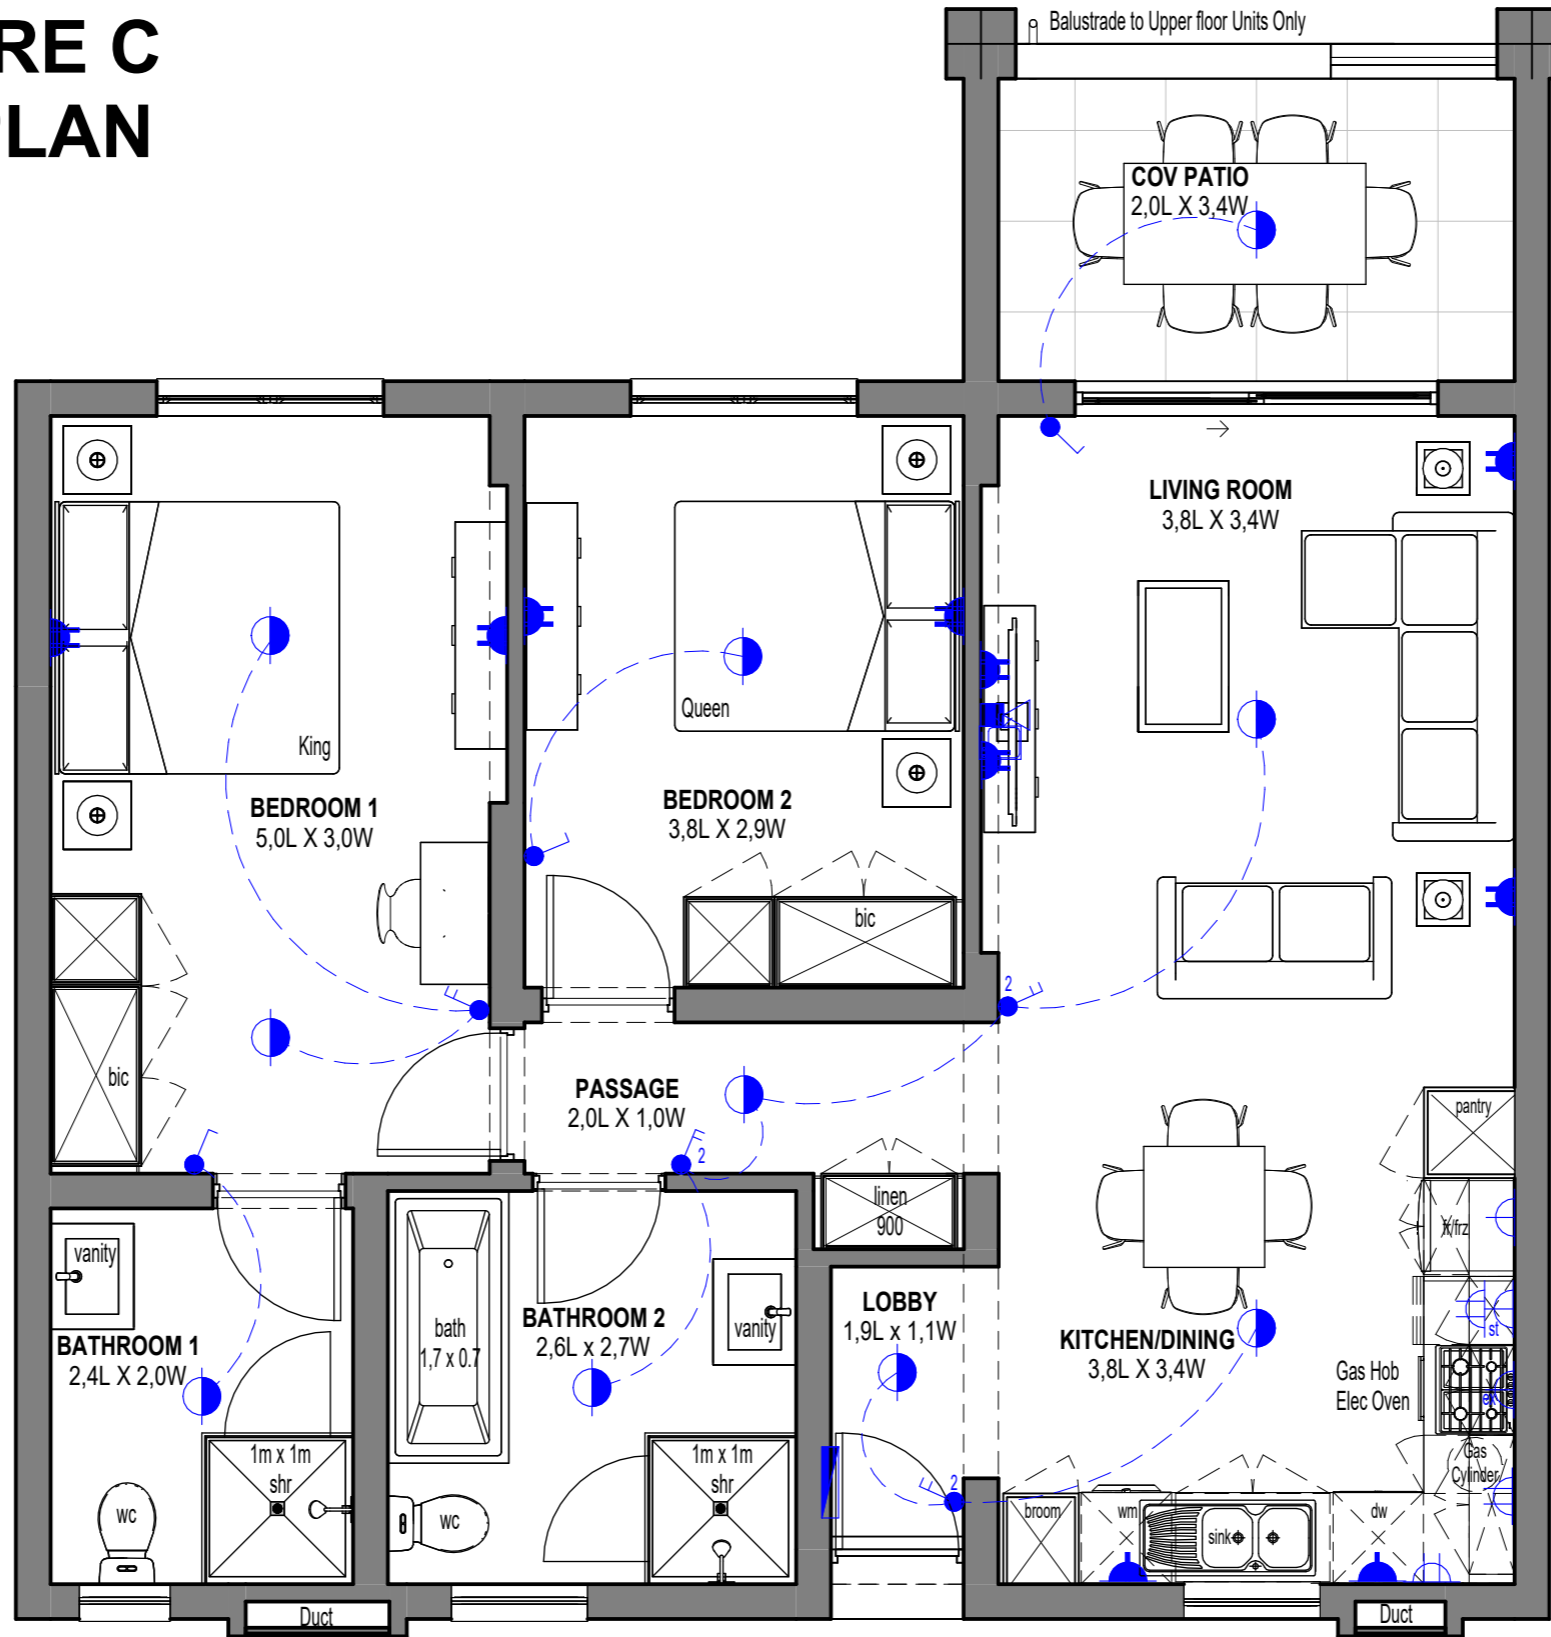
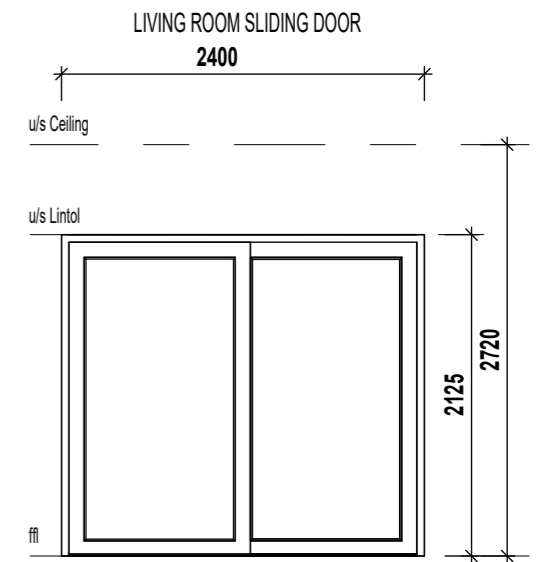


# ANNEXURE C FLOOR PLAN

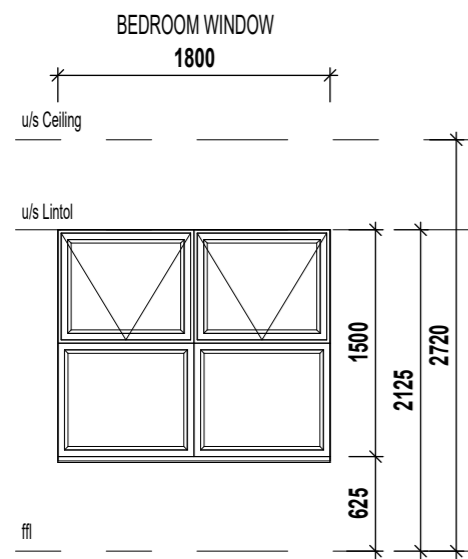

2 Bedroom - 2 Bathroom

SCALE 1:50

D8

**ELECTRICAL LEGEND**

- Surface Mounted LED Fitting
- External Wall Mounted LED Light Fitting
- LED Strip Light Fitting (u/s - Eye levels - Kitchen)
- Single Light Switch
- Double Light Switch
- Triple Light Switch
- Two-Way Light Switch
- Single Plug Point (300mm Above FFL)
- Double Plug Point (300mm Above FFL)
- Single Plug Point (150mm Above Counter)
- Double Plug Point (150mm Above Counter)
- Stove Isolator (Above Counter)
- Extractor Plug (High Level)
- Distribution Board
- TV Point
- Fibre / Data Point
- Inverter

AREA TYPE D8	
Floor Area	82.81 m <sup>2</sup>
Cov Balcony	8.64 m <sup>2</sup>
<b>Total</b>	<b>91.45 m<sup>2</sup></b>

\* The areas are approximate and shall vary from the areas reflected on the sectional title plan